

Consultants:

Revisions:

Rev	Date	Description


Seal:

**PRELIMINARY DESIGN  
 SUBMISSION  
 NOT FOR CONSTRUCTION**

Date: 12.29.2012  
 Scale: AS NOTED  
 Drawn By: KTE/SAA  
 Reviewed By: MPM  
 Checked By: STG  
 Approved By: JFB

Drawing Title:  
**SITE PLAN**

Sheet Number:  
**SP1.0**

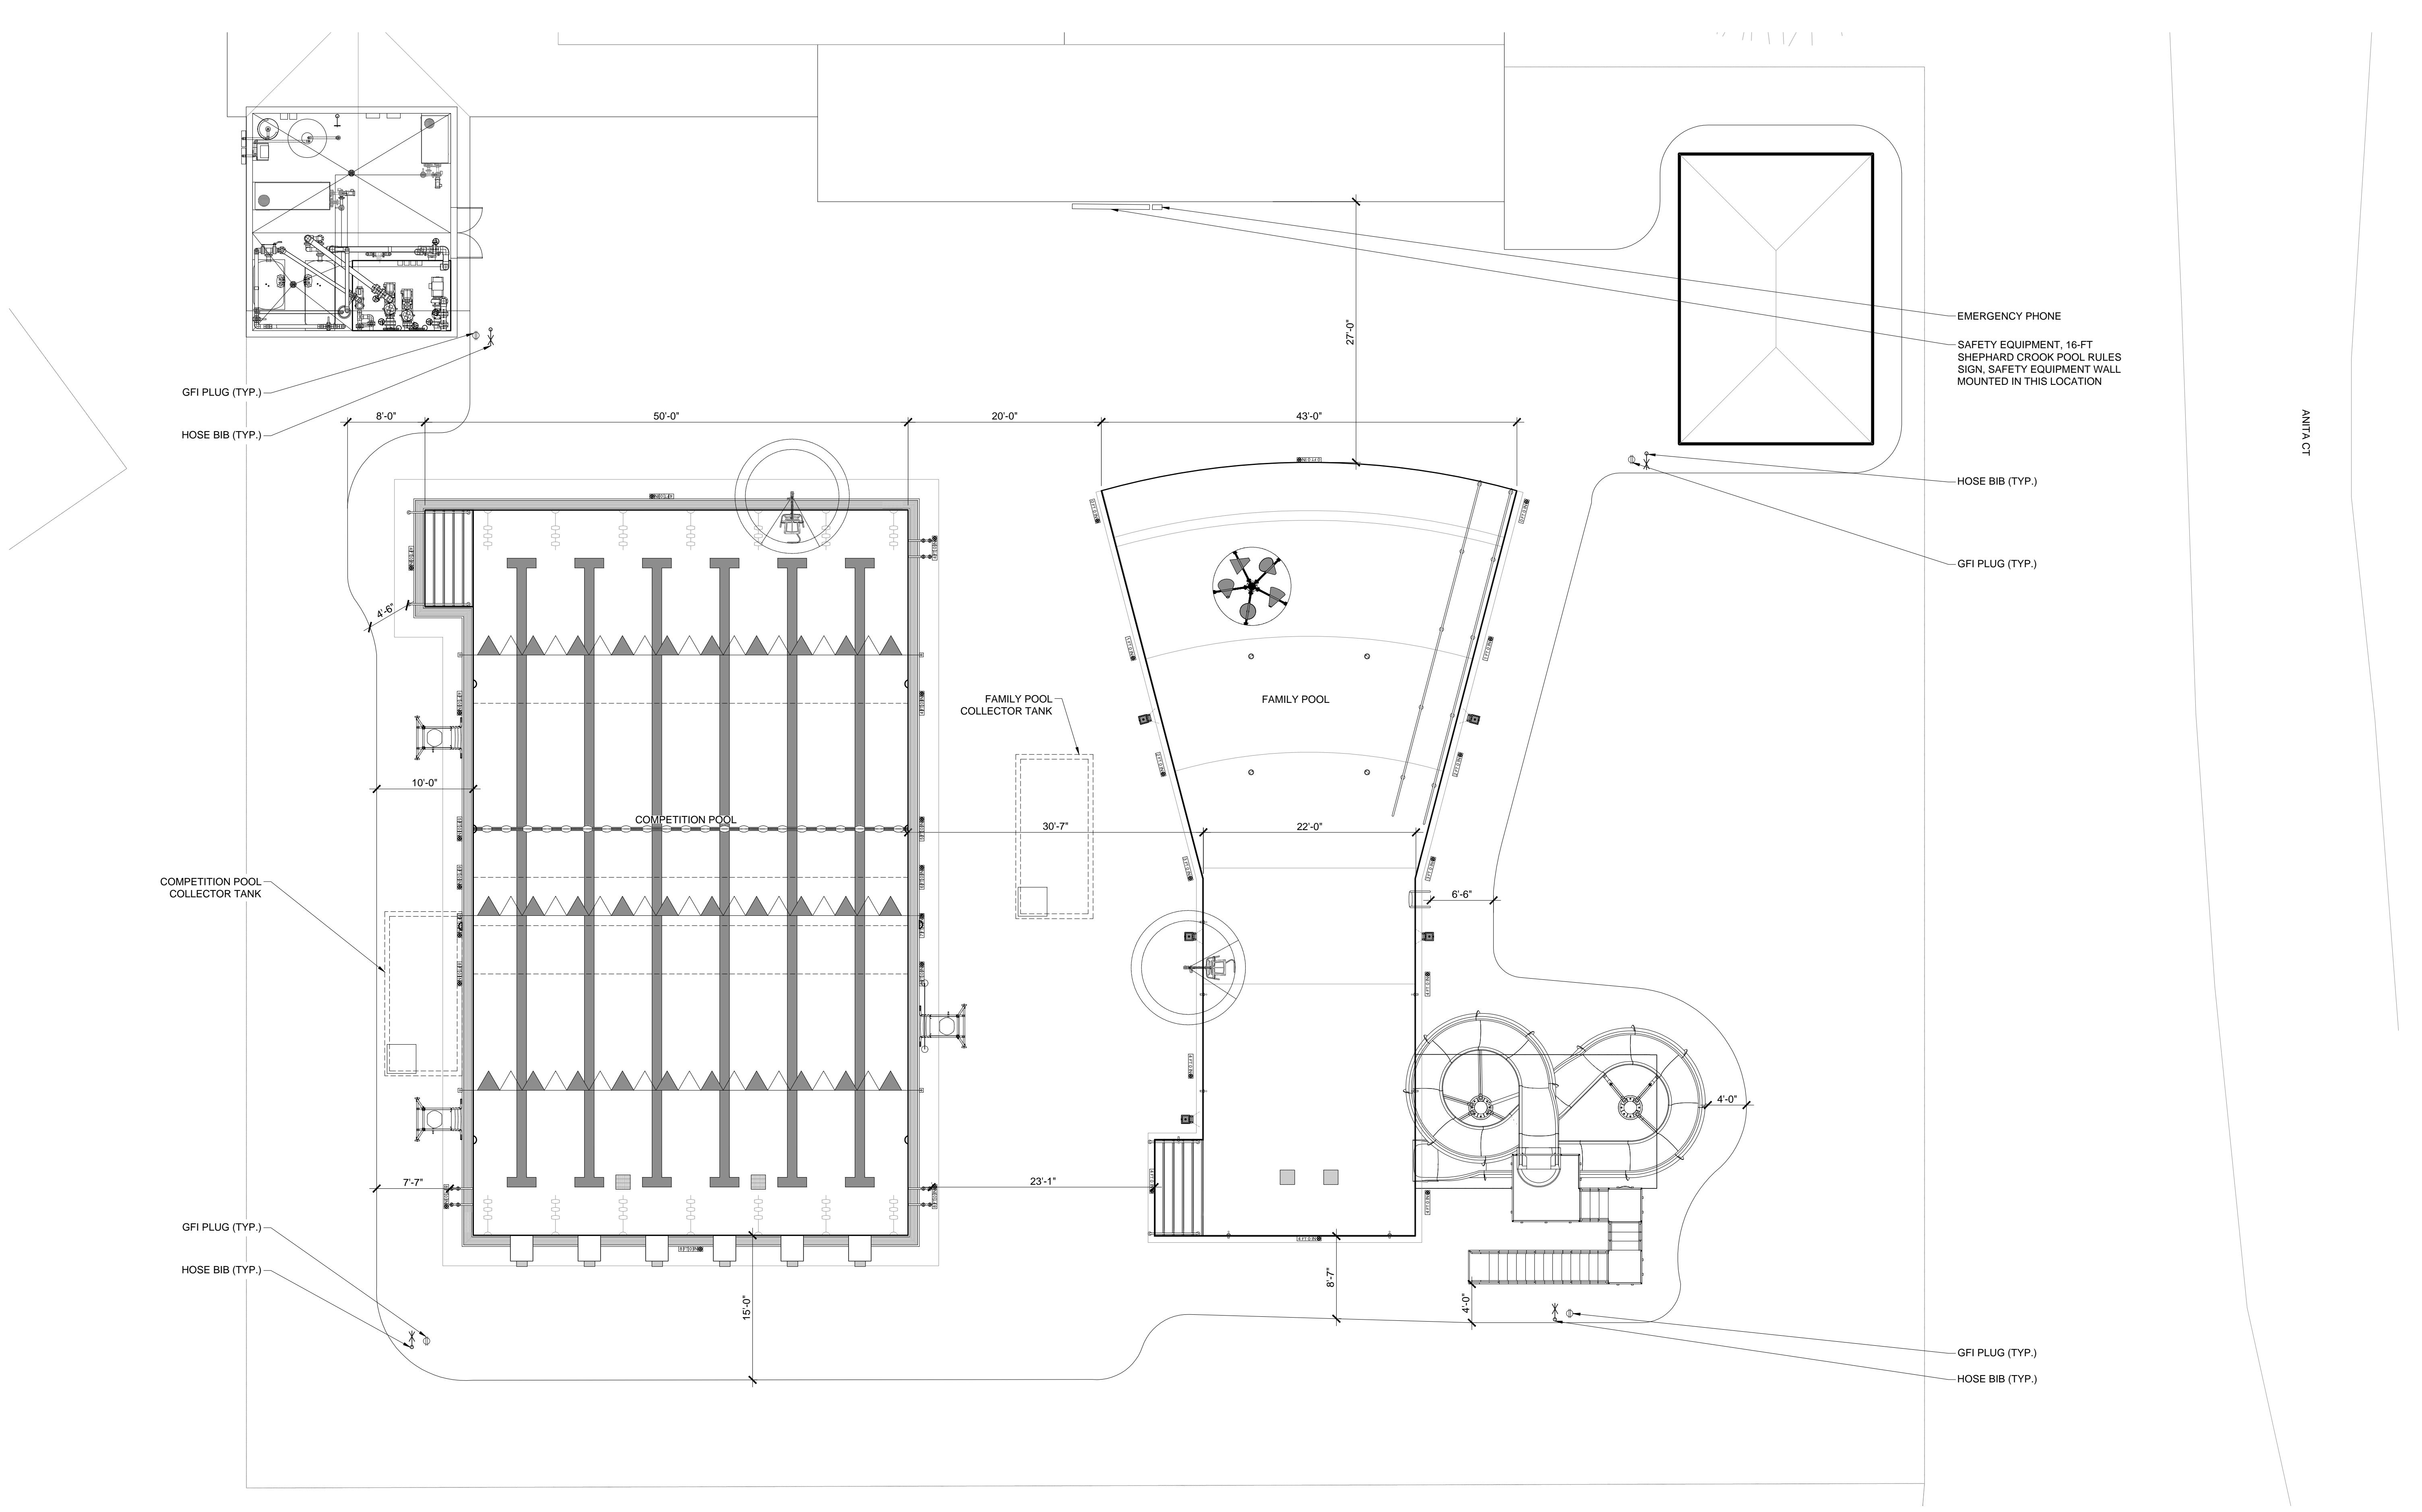

**POOL PLAN VIEW**  
 SCALE: 1/8" = 1'-0"

- NOTES:
1. ALL DOORS LEADING TO THE POOL AREAS SHALL BE SELF CLOSING SELF LATCHING.
  2. ALL DECK SURFACES SHALL BE SLIP RESISTANT.
  3. SHOWERS ARE LOCATED WITHIN THE MEN'S AND WOMEN'S LOCKER ROOMS.
  4. DECK SURFACE SHALL BE CONCRETE.

THE ELECTRICAL CONTRACTOR SHALL GROUND AND BOND ALL ELECTRICAL EQUIPMENT, POOL REINFORCING, POOL ACCESSORIES, AND PIPING IN ACCORDANCE WITH NATIONAL ELECTRIC CODE REQUIREMENTS, ARTICLE 680. THE ELECTRICAL CONTRACTOR SHALL OBTAIN A COPY OF ALL APPLICABLE LOCAL STATE ELECTRICAL CODE REGULATIONS.

\\w03\lsc\WES\Projects\MA\_Boston\OldServer\Vaughan\Winooski\_VT\CAD\REV\0-CURRENT\SEA\Sheets\SP1.dwg